


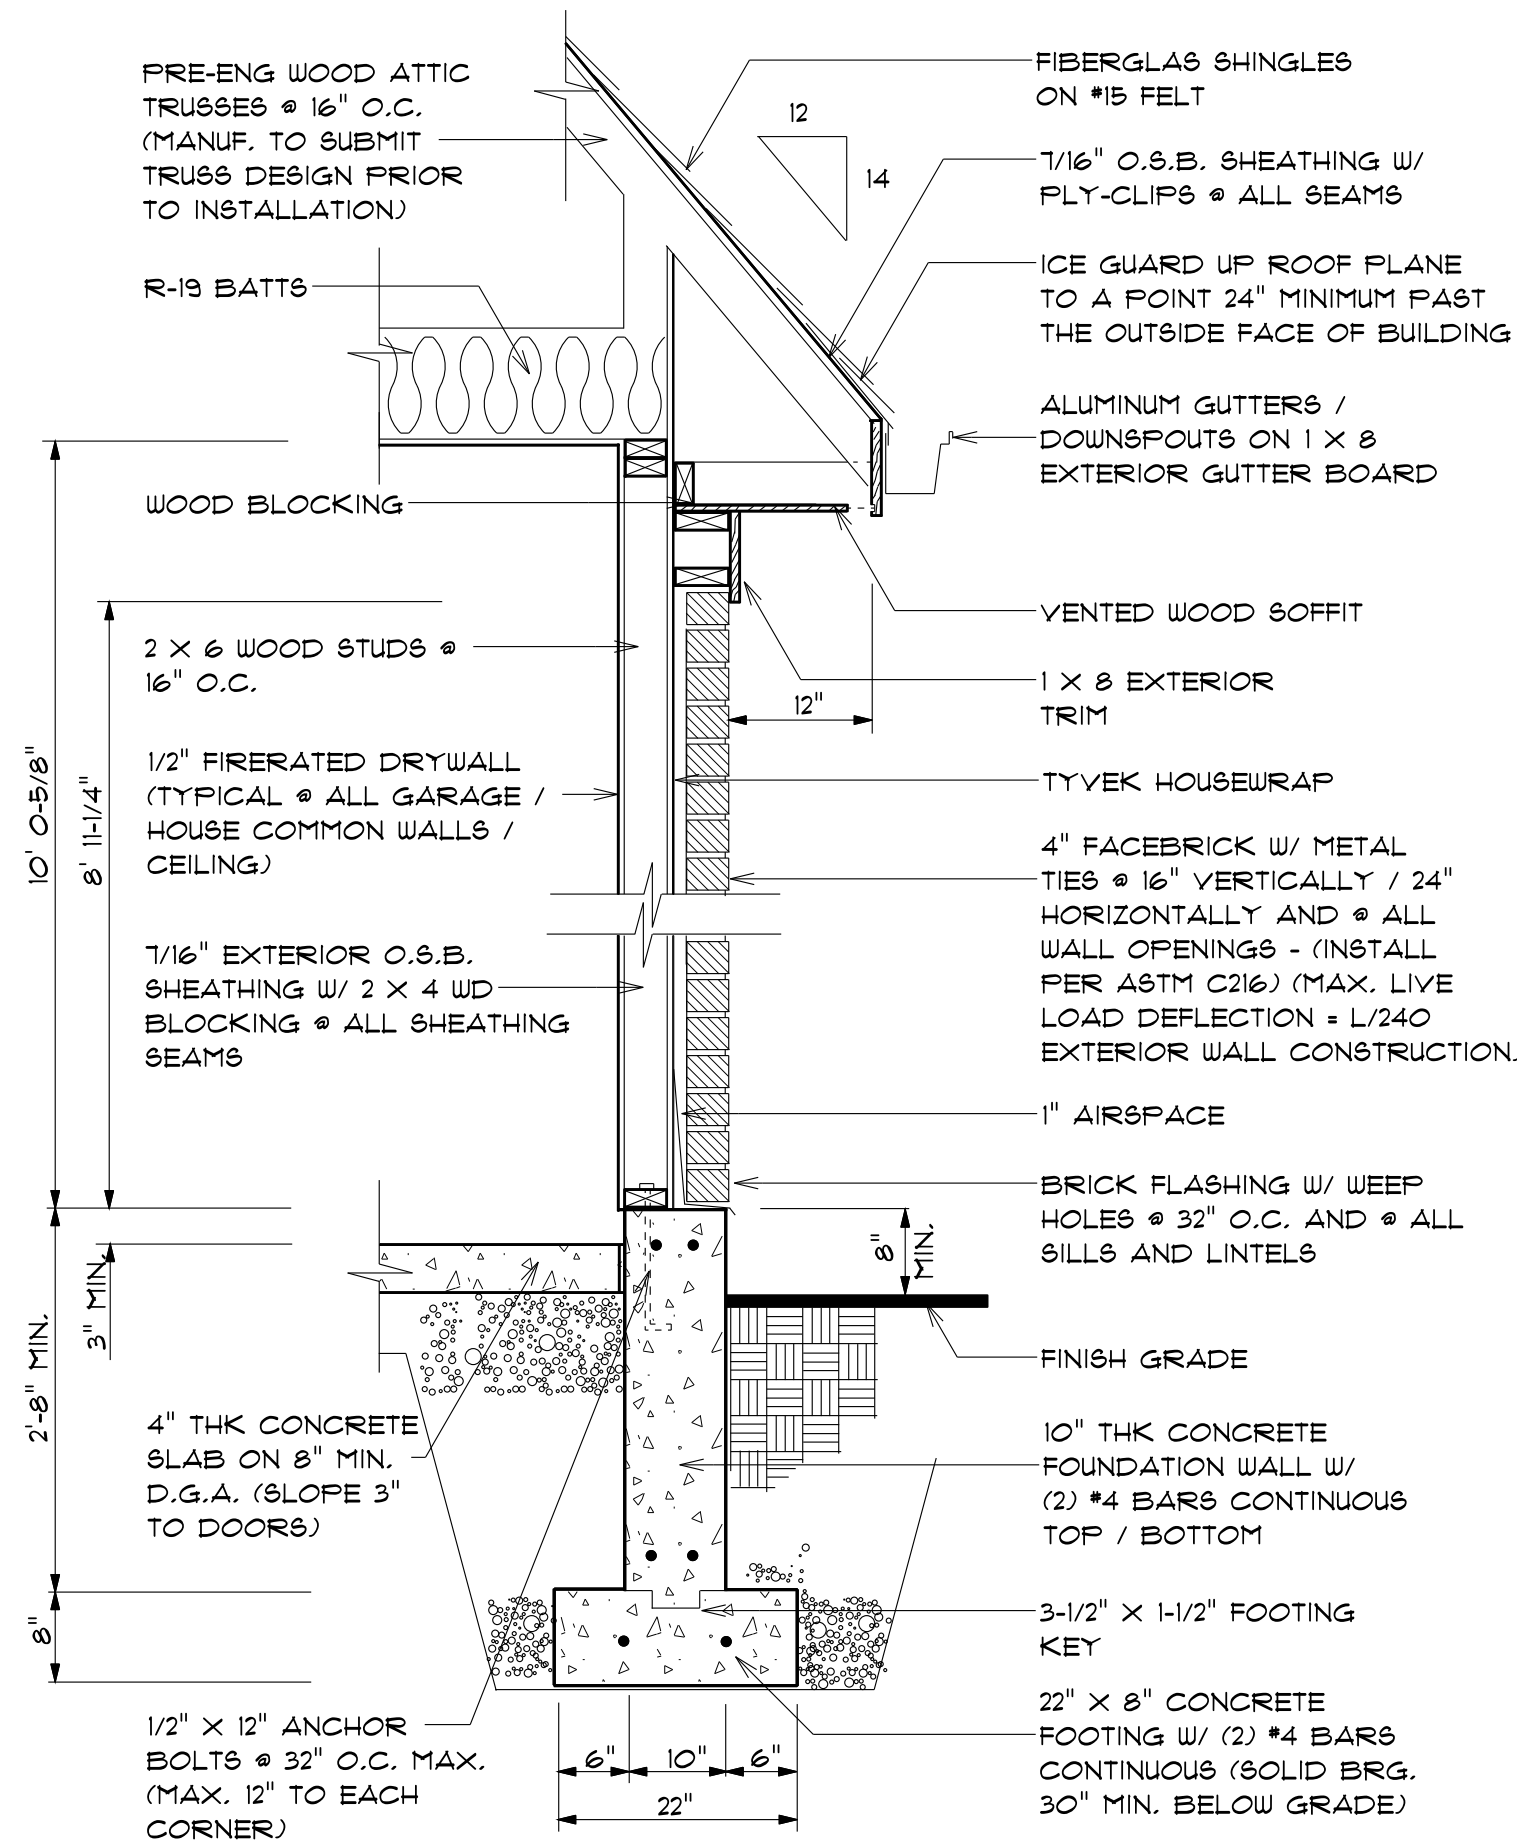

garage section
at loft

scale: 3/4" = 1'-0"

drawing index

SHEET	DESCRIPTION
A-1	INDEX / FRONT ELEVATION / WALL TYPES
A-2	REAR ELEVATION
A-3	RIGHT AND LEFT SIDE ELEVATIONS
A-4	FOUNDATION PLAN
A-5	FIRST FLOOR PLAN
A-6	SECOND FLOOR PLAN
A-7	ROOF STRUCTURE PLAN
A-8	WALL SECTIONS / ELECTRICAL PLANS
A-9	BUILDING / STAIR SECTION
A-10	GENERAL NOTES

NOTE: ENERGY COMPLIANCE SHALL BE SHOWN BY COST COMPLIANCE METHOD, SIMULATED PERFORMANCE PATH. (METHOD #1 IECC, CHAPTER 110.2 2013 RCO)

wall types

WALL	DESCRIPTION
	2 X 4 WOOD STUDS @ 16" O.C.
	2 X 4 WOOD STUDS @ 16" O.C. W/ BRICK VENEER
	2 X 6 WOOD STUDS @ 16" O.C. W/ BRICK VENEER
	NEW CONCRETE FOUNDATION WALL
	2 X 4 WOOD STUDS @ 16" O.C. W/ SIDING
	2 X 4 WOOD STUDS @ 16" O.C. W/ STONE VENEER
	2 X 6 WOOD STUDS @ 16" O.C. W/ STONE VENEER
	STEP DOWN TOP OF FOUNDATION WALL



front elevation

scale: 1/4" = 1'-0"

JOSEPH A. BROWN
REGISTERED ARCHITECT, P.L.C.

P.O. BOX 1045
WARSAW, KENTUCKY 40385
PHONE: 502-651-6111

RESIDENCE FOR
BRAD AND MISTY MEYER
SITE #23 THE HIGHLANDS WARREN COUNTY, OHIO
HENSLEY HOMES

Drawn JAB	Revision
Date 5/3/18	Job 11011
Title	

A-1
Sheet 1 of 8